

**PROJECT:-**

**PROPOSED  
INJECTION MouldING  
FACTORY FOR  
ANTE LECO METERING  
COMPANY AT  
BANDARAGAMA**

**TITLE**


**ELECTRICAL LAYOUT  
GROUND FLOOR**

**NOTES**

THIS DRAWING MUST NOT BE COPIED OR USED BY OTHERS WITHOUT THE WRITTEN CONSENT OF ARCHITREND CONSULTANTS.

ALL DIMENSION ARE IN MILLIMETERS


DESIGNATION	NAME
Principal Architect	L.S. Perera
Electrical Engineer	S.R.Hiranthika
Drawn by	DTN
Checked by	
Drawing No	AT/LECO/BAN/4417/TEND/ELE/01
Drawing Path	
Date	Issued Date
27 - April - 2016	Scale NTS
REVISION	Date
Revise Drawing No	Drawn by
Applicant Signature	Sheet no :-

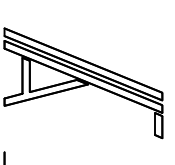

**01-ELE**

**ARCHITREND CONSULTANTS**

Chartered Architects, Engineers,  
Quantity Surveyors &  
Interior Designers.  
No.35,  
Vihara Mawatha,  
Pepilyana,  
Tel : 011 - 4337787  
Fax : 011 - 2724755  
E - mail : architrendsp@gmail.com  
Web : www.architrend.lk

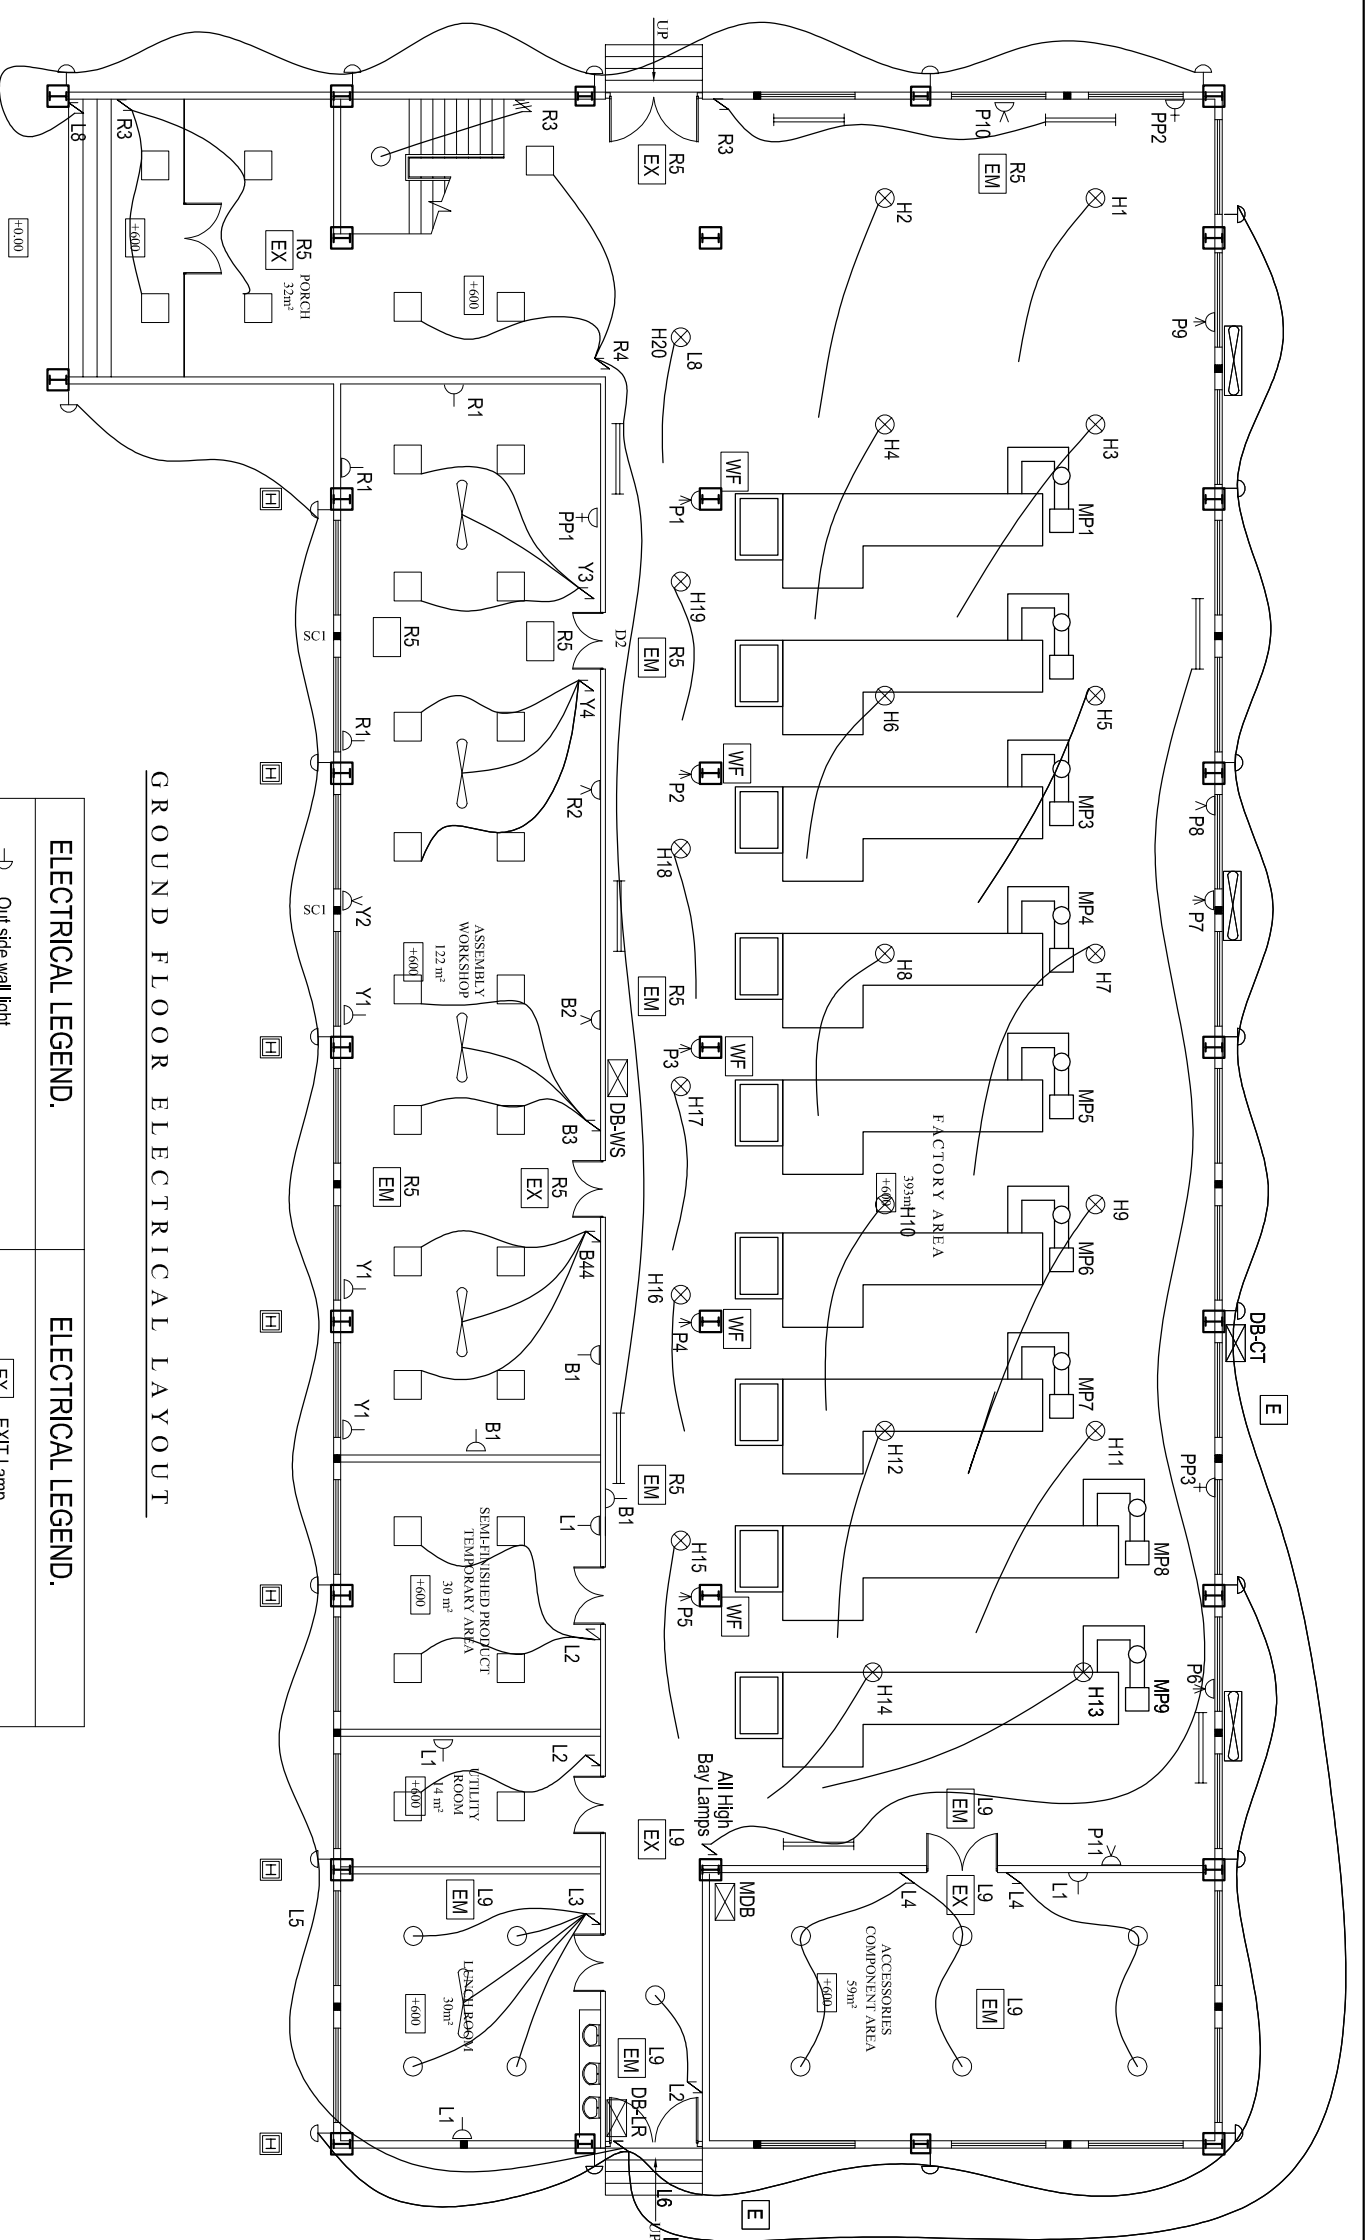

**GROUND FLOOR ELECTRICAL LAYOUT**

ELECTRICAL LEGEND.		ELECTRICAL LEGEND.	
→	Out side wall light	EX	EXIT Lamp
⊗	High Bay Lamp	EM	Emergency Lamp
—	Fluorescent light	EF	Exhaust Fan
D+	16A Spin ISO	BP	Bell Push
D<	15A socket outlet with 20A Two Pole Switch	B	Bell Unit
D<	15A socket outlet	LED	LED Panel Lamp
D-	13A Twin Socket Outlet	WF	Wall Fan
∩	One way switch	○	pendent Lamp
≡	Two way switch	□	AC indoor unit
⊕	Ceiling fan	□	AC outdoor unit
⊞	Power Distribution Board		
E	Earth Electrode		