

PROJECT:-
PROPOSED
INJECTION MouldING
FACTORY FOR
ANTE LECO METERING
COMPANY AT
BANDARAGAMA

TITLE
ELECTRICAL LAYOUT
UPPER FLOOR

NOTES

THIS DRAWING MUST NOT BE COPIED OR USED BY OTHERS WITHOUT THE WRITTEN CONSENT OF ARCHITREND CONSULTANTS.

ALL DIMENSION ARE IN MILLIMETERS

DESIGNATION	NAME
Principal Architect	L.S. Perera
Electrical Engineer	S.R.Hiranthika
Drawn by	DTN
Checked by	
Drawing No	AT/LECO/BAN/441/TEND/ELE/02
Drawing Path	
Date	Issued Date
27 - April - 2016	Scale
	NTS
REVISION	Date
Revise Drawing No	Drawn by
Applicant Signature	

Sheet no :-

02-ELE

ARCHITREND CONSULTANTS

Chartered Architects, Engineers,
 Quantity Surveyors &
 Interior Designers.

No.35,
 Vihara Mawatha,


Pepilyana.

Tel : 011 - 4337787

Fax : 011 - 2724755

E - mail : architrendsp@gmail.com

Web : www.architrend.lk

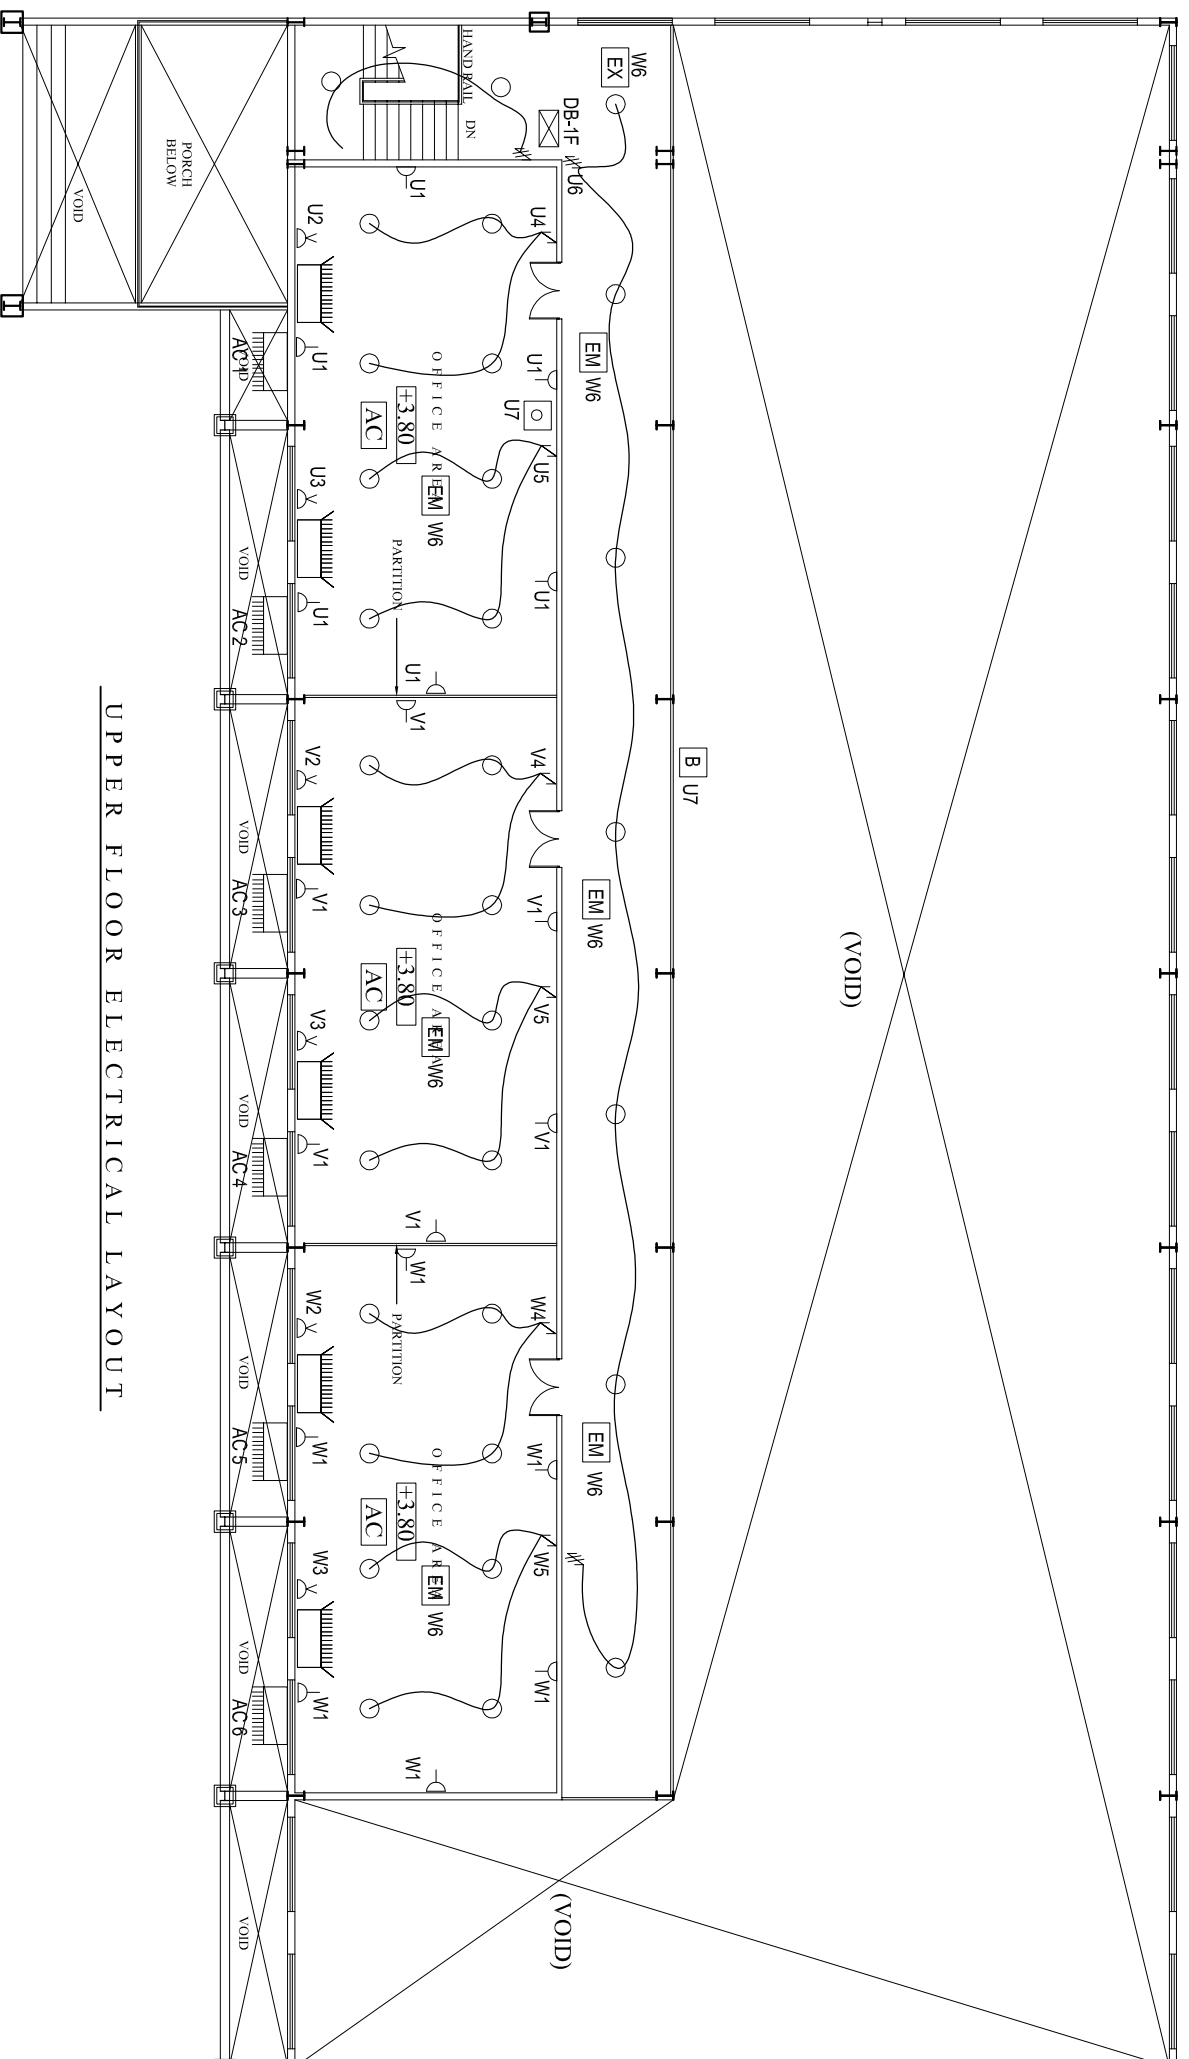

UPPER FLOOR ELECTRICAL LAYOUT

ELECTRICAL LEGEND.	ELECTRICAL LEGEND.
→ Out side wall light	EX EXIT Lamp
⊗ High Bay Lamp	EM Emergency Lamp
— Fluorecent light	EF Exhaust Fan
D+ 16A 5pin ISO	BP Bell Push
D< 15A socket outlet with 20A Two Pole Switch	B Bell Unit
D< 15A socket outlet	LED Panel Lamp
D- 13A Twin Socket Outlet	WF Wall Fan
∨ One way switch	○ pendant Lamp
# Two way switch	□ AC indoor unit
⊞ Ceiling fan	□ AC outdoor unit
⊞ Power Distribution Board	
E Earth Electrode	